
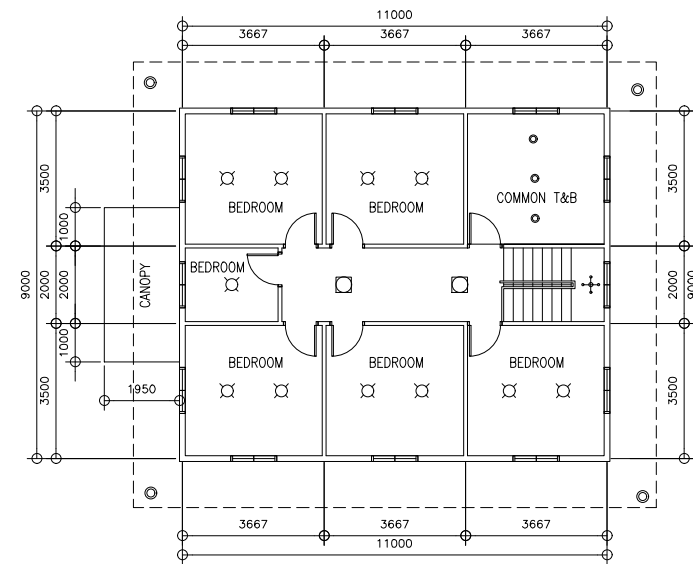


LEGEND	
	6" RECESSED TYPE DOWNLIGHT
	8" TUBULAR TYPE HOUSING, WITH LED BULB
	4" TUBULAR TYPE HOUSING, WITH LED BULB
	4" RECESSED TYPE DOWNLIGHT
	CHANDELIER
	INDUSTRIAL TYPE, T8 BULB
	LAMP POST

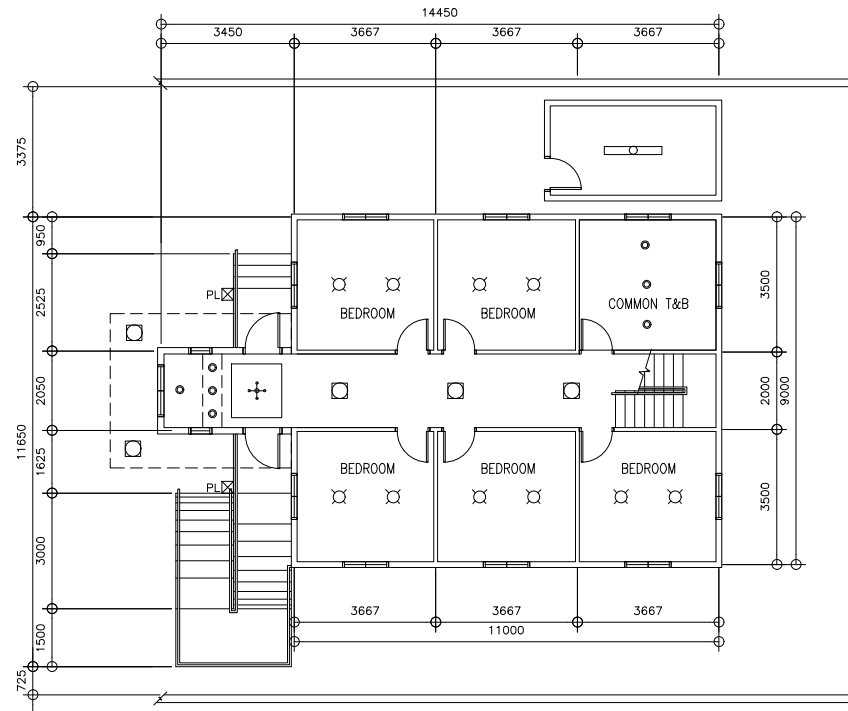

1  
E-1

## GROUND FLOOR LIGHTING LAYOUT

SCALE 1:200M


2  
E-1

## SECOND FLOOR LIGHTING LAYOUT

SCALE 1:200M

<p>REPUBLIC OF THE PHILIPPINES DEPARTMENT OF EDUCATION EDUCATION FACILITIES DIVISION MERALCO AVENUE, PASIG CITY</p>	<p>DRAWN BY :</p> <p></p> <p><b>JESTER SETH B. CALIXTO</b> ELECTRICAL ENGINEER EFD-DepED</p>	<p>CHECKED BY :</p> <p></p> <p><b>SIGMUND M. SANCHEZ</b> PROFESSIONAL ELECTRICAL ENGINEER EFD-DepED</p>	<p>RECOMMENDING APPROVAL :</p> <p></p> <p><b>ANNABELLE R. PANGAN</b> CHIEF, EFD DepED</p>	<p>RECOMMENDING APPROVAL :</p> <p></p> <p><b>DIOSDADO S. MEDINA</b> CAMP SUPERINTENDENT BAGUIO TEACHERS CAMP</p>	<p>APPROVED BY :</p> <p></p> <p><b>NOLASCO A. MEMPIN</b> UNDERSECRETARY FOR ADMINISTRATION DepED</p>	<p>PROJECT TITLE :</p> <p><b>REPAIR AND REHABILITATION OF BACHELORS HALL</b></p> <p>LOCATION : BAGUIO TEACHERS CAMP</p>	<p>PROJECT CODE:</p>	<p>OWNER :</p> <p><b>DEPARTMENT OF EDUCATION DepED</b></p> <p>SHEET CONTENTS :</p> <p>GROUND FLOOR LIGHTING LAYOUT SECOND FLOOR LIGHTING LAYOUT</p>	<p>SHEET NO:</p> <p><b>E-1</b> <b>4</b></p>
---	--	---	---	--	--	---	----------------------	---	---


LEGEND	
	DUPLEX CONVENIENCE OUTLET
	WEATHERPROOF DUPLEX CONVENIENCE OUTLET
	PANELBOARD

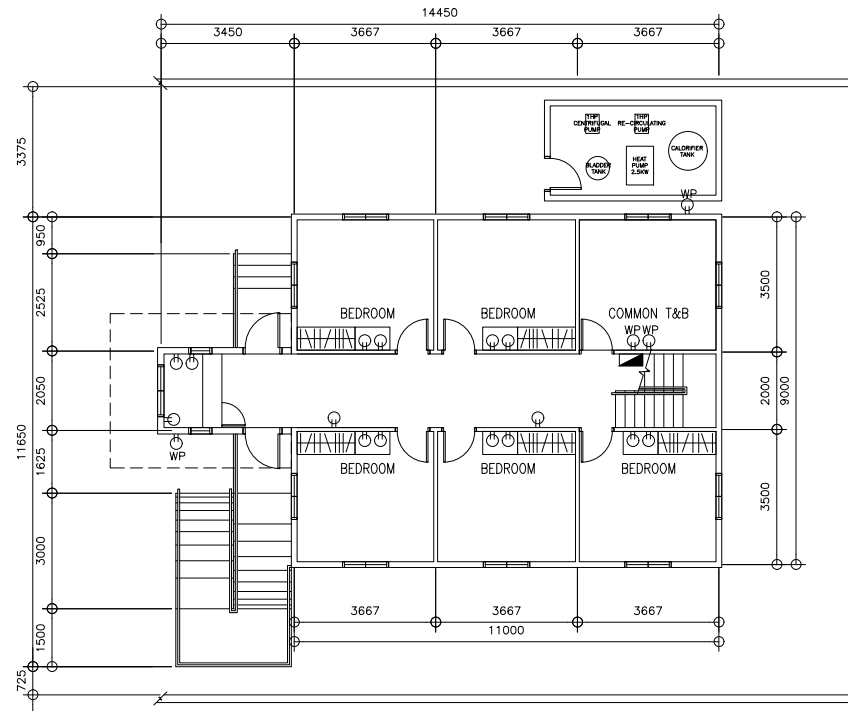

1  
E-2

## GROUND FLOOR POWER LAYOUT

SCALE 1:200M

 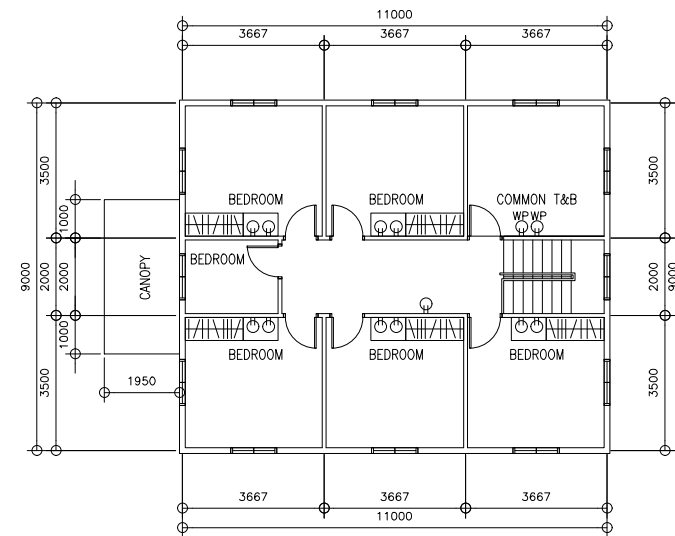



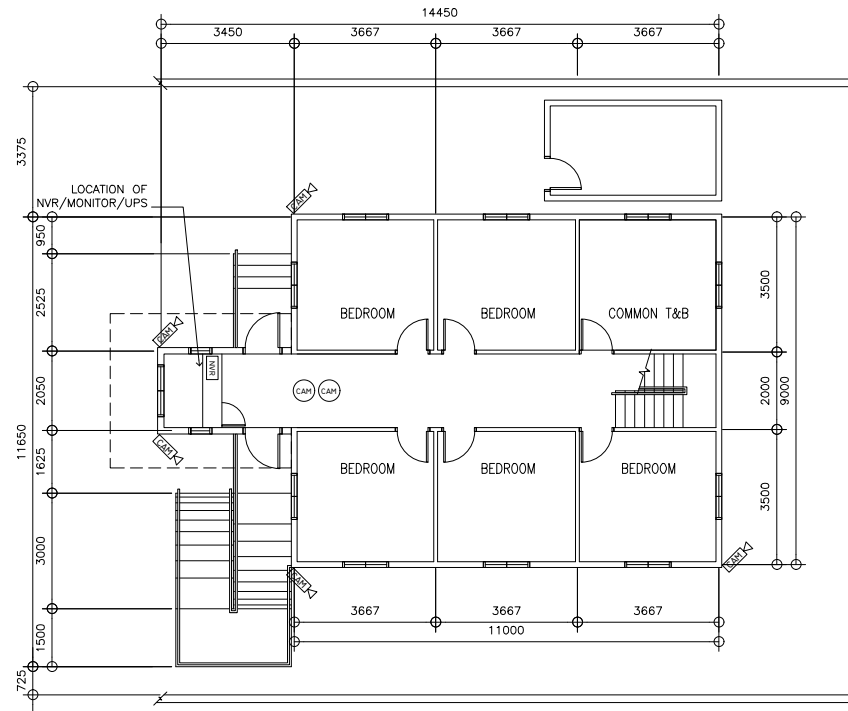
2  
E-2

## SECOND FLOOR POWER LAYOUT


SCALE 1:200M

<p>REPUBLIC OF THE PHILIPPINES DEPARTMENT OF EDUCATION EDUCATION FACILITIES DIVISION MERALCO AVENUE, PASIG CITY</p>	DRAWN BY :  <b>JESTER SETH B. CALIXTO</b> ELECTRICAL ENGINEER EFD-DepED	CHECKED BY :  <b>SIGMUND M. SANCHEZ</b> PROFESSIONAL ELECTRICAL ENGINEER EFD-DepED	RECOMMENDING APPROVAL :  <b>ANNABELLE R. PANGAN</b> CHIEF, EFD DepED	RECOMMENDING APPROVAL :  <b>DIOSDADO S. MEDINA</b> CAMP SUPERINTENDENT BAGUIO TEACHERS CAMP	APPROVED BY :  <b>NOLASCO A. MEMPIN</b> UNDERSECRETARY FOR ADMINISTRATION DepED	PROJECT TITLE : <b>REPAIR AND REHABILITATION OF BACHELORS HALL</b>	PROJECT CODE:	OWNER : <b>DEPARTMENT OF EDUCATION DepED</b>	SHEET NO.: <b>E-2</b> <b>4</b>
	LOCATION : BAGUIO TEACHERS CAMP						SHEET CONTENTS : GROUND FLOOR POWER LAYOUT SECOND FLOOR POWER LAYOUT		





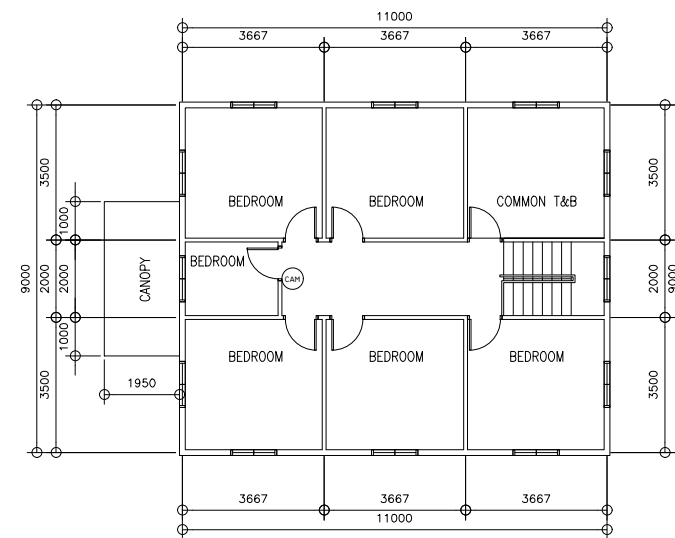

LEGEND	
	BULLET/DOME TYPE CAMERA
	NETWORK VIDEO RECORDER





1 GROUND FLOOR CCTV LAYOUT  
E-3 SCALE 1:200M



2 SECOND FLOOR CCTV LAYOUT  
E-3 SCALE 1:200M

 <p>REPUBLIC OF THE PHILIPPINES DEPARTMENT OF EDUCATION EDUCATION FACILITIES DIVISION MERALCO AVENUE, PASIG CITY</p>	DRAWN BY :  <b>JESTER SETH B. CALIXTO</b> ELECTRICAL ENGINEER EFD-DepED	CHECKED BY :  <b>SIGMUND M. SANCHEZ</b> PROFESSIONAL ELECTRICAL ENGINEER EFD-DepED	RECOMMENDING APPROVAL :  <b>ANNABELLE R. PANGAN</b> CHIEF, EFD DepED	RECOMMENDING APPROVAL :  <b>DIOSDADO S. MEDINA</b> CAMP SUPERINTENDENT BAGUIO TEACHERS CAMP	APPROVED BY :  <b>NOLASCO A. MEMPO</b> UNDERSECRETARY FOR ADMINISTRATION DepED	PROJECT TITLE : <b>REPAIR AND REHABILITATION OF BACHELORS HALL</b>  LOCATION : BAGUIO TEACHERS CAMP	PROJECT CODE:  	OWNER : <b>DEPARTMENT OF EDUCATION DepED</b>  SHEET CONTENTS : GROUND FLOOR CCTV LAYOUT SECOND FLOOR CCTV LAYOUT	SHEET NO: <div style="border: 1px solid black; border-radius: 50%; width: 40px; height: 40px; display: flex; align-items: center; justify-content: center; margin: 0 auto;"> <div style="text-align: center;"> <p>E-3</p> <p>4</p> </div> </div>
---	--	---	---	--	---	--	-----------------------	---	---

LEGEND	
○SD	SMOKE DETECTOR
⊠SP	SPEAKER
⊠	2-BEAM EMERGENCY LIGHT
⊠MS	MANUAL STATION
○FB	FIRE ALARM BELL
⊠AMP	AMPLIFIER
⊠EXIT	EXIT SIGNAGE

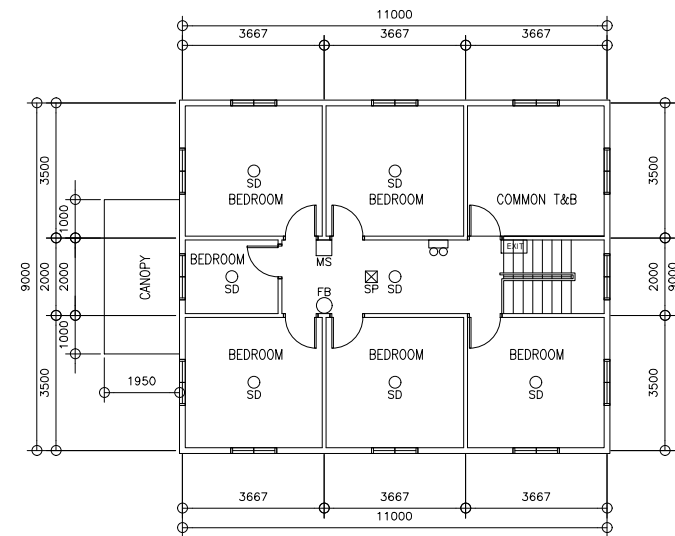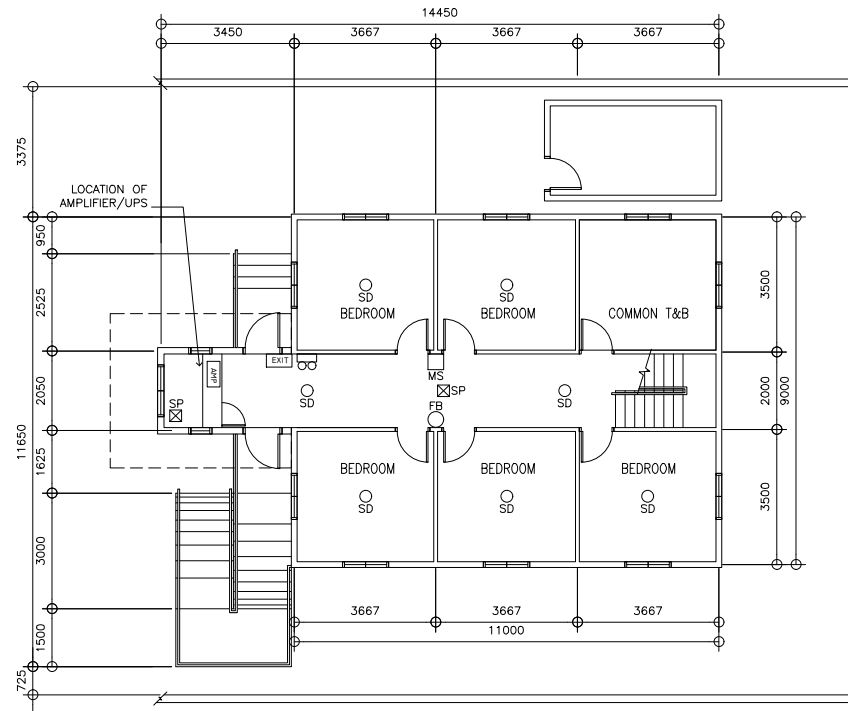

1  
E-4  
SCALE  
**GROUND FLOOR AUDIO/FIRE LAYOUT**  
1:200M

2  
E-4  
SCALE  
**SECOND FLOOR AUDIO/FIRE LAYOUT**  
1:200M

<p>REPUBLIC OF THE PHILIPPINES DEPARTMENT OF EDUCATION EDUCATION FACILITIES DIVISION MERALCO AVENUE, PASIG CITY</p>	<p>DRAWN BY :</p> <p><i>Jester Seth B. Calixto</i> JESTER SETH B. CALIXTO ELECTRICAL ENGINEER EFD-DepED</p>	<p>CHECKED BY :</p> <p><i>Siegmund M. Sanchez</i> SIEGMUND M. SANCHEZ PROFESSIONAL ELECTRICAL ENGINEER EFD-DepED</p>	<p>RECOMMENDING APPROVAL :</p> <p><i>Annabelle R. Pangan</i> ANNABELLE R. PANGAN CHIEF, EFD DepED</p>	<p>RECOMMENDING APPROVAL :</p> <p><i>Diosdado S. Medina</i> DIOSDADO S. MEDINA CAMP SUPERINTENDENT BAGUIO TEACHERS CAMP</p>	<p>APPROVED BY :</p> <p><i>Nolasco A. Mempin</i> NOLASCO A. MEMPIN UNDERSECRETARY FOR ADMINISTRATION DepED</p>	<p>PROJECT TITLE :</p> <p>REPAIR AND REHABILITATION OF BACHELORS HALL</p>	<p>PROJECT CODE:</p>	<p>OWNER :</p> <p>DEPARTMENT OF EDUCATION DepED</p>	<p>SHEET NO:</p> <p>E-4 4</p>
	<p>LOCATION : BAGUIO TEACHERS CAMP</p>						<p>SHEET CONTENTS :</p> <p>GROUND FLOOR PLAN AUDIO/FIRE LAYOUT SECOND FLOOR PLAN AUDIO/FIRE LAYOUT</p>		